


RDS No	EQUIPMENT LIST	DESCRIPTION
4809/A4/K	SUPPLY & STANDBY FANS	
4806/NED/142	NON RETURN DAMPERS	
4809/FS/1	FEE GAS DAMPER	
4809/A45/K	SUPPLY & STANDBY FANS	
4809/NED/142	NON RETURN DAMPERS	
4811/A45/K	SUPPLY & STANDBY FANS	
4811/EXT/4	EXTACT & STANDBY DAMPERS	
4811/NED/1-4	NON RETURN DAMPERS	
4811/EXT/3	EXTERNAL LOUVERS	
4811/SE/12	SALT ELIMINATOR	
4811/HE/13.67	AIR HEATER BATTERIES	
4811/TCV/1-3.6-8	TEMPERATURE CONTROL VALVES	
4811/SE/8	AIR COOLING BATTERY	
4811/FS/1-3	SILENCERS	

TITLE	DRG. No.
H.V.A.C. FLOWSHEET TO BULK STORAGE	A1-1-4800-35
H.V.A.C. FLOWSHEET TO BOILER ROOM & WORKSHOP	A1-1-4800-44
H.V.A.C. FLOWSHEET TO ENGINE & GENERATOR ROOM	A1-1-4800-56
H.V.A.C. FLOWSHEET TO DRILLERS CHANGING ROOM & CONTROL ROOMS	A1-1-4800-61
H.V.A.C. LAYOUT TO HANGING ROOM CONTROL ROOMS OFFICES & MUD LOGGING ROOM	A1-1-4800-62
FAN SCHEDULE	A1-1-4800-50
HEATER BATTERY SCHEDULE	A1-1-4800-51

- NOTES**
1. ALL DUCT SIZES ARE INTERNAL
  2. THERMOSTATIC CONTROL VALVES ARE TO BE SUPPLIED BY H.V.A.C. CONTRACTOR AND INSTALLED BY OTHERS.
  3. WIRE MESH IS TO BE FITTED OVER EXTERNAL LOUVERS, OPEN ENDS OF FANS DAMPERS AND OPEN ENDS OF FANS.
  4. ACOUSTIC INSULATION TO BE APPLIED BETWEEN SILENCERS AND PLANT/ROOM BOUNDARY.

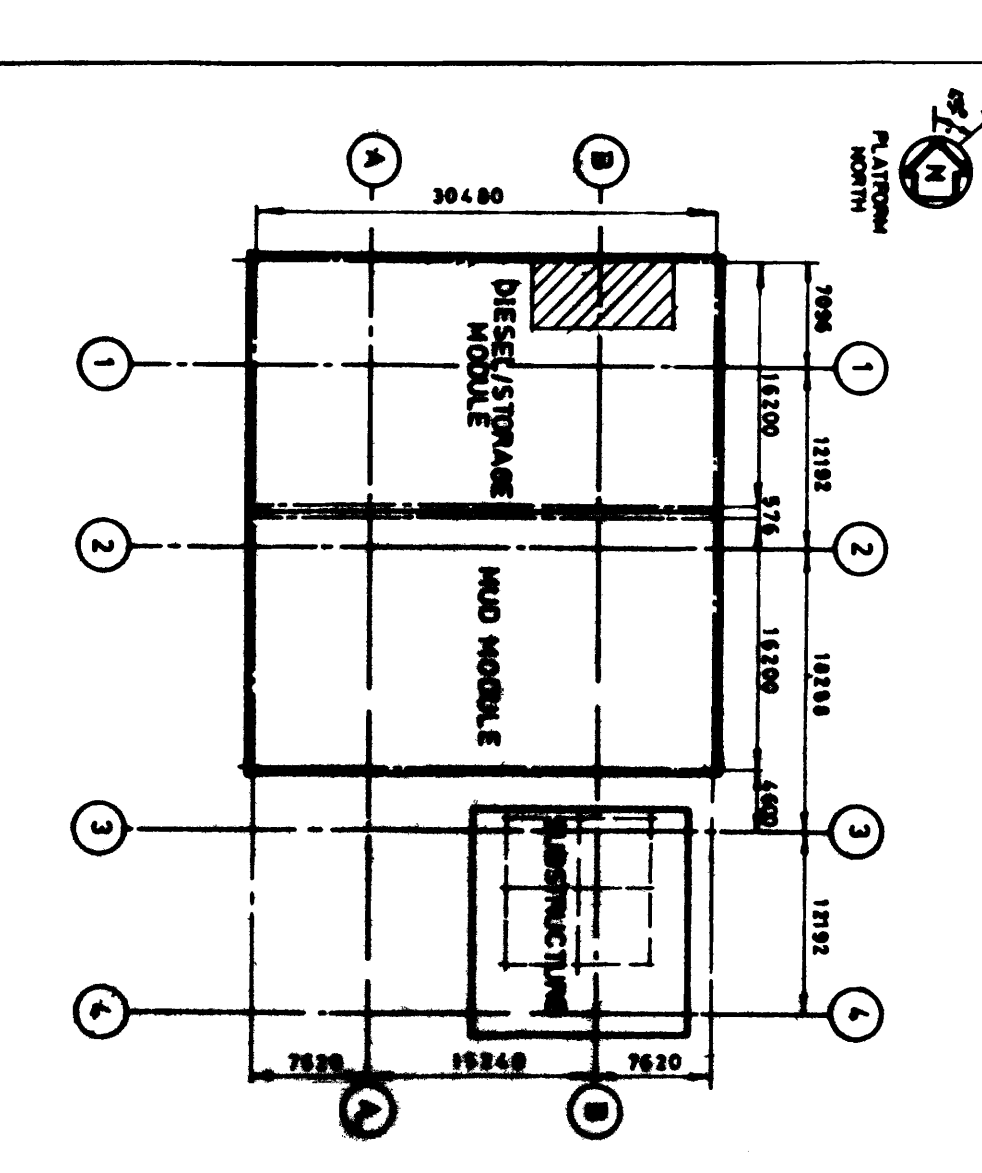

**APPROVED FOR ISSUE**

SIGNED - \_\_\_\_\_ DATE - \_\_\_\_\_

**RIG DESIGN SERVICES LTD**  
CONSULTING ENGINEERS

CLIENT: AMOCO  
PROJECT: VALHALL DEVELOPMENT

H.V.A.C. PLANTROOM LAYOUT (DIESEL MODULE)

SCALE: 1:25

DATE: 21/12/80

REVISIONS:

NO.	DESCRIPTION	DATE
1	ISSUED FOR CONSTRUCTION	21/12/80
2	ISSUED FOR CONSTRUCTION	21/12/80
3	ISSUED FOR CONSTRUCTION	21/12/80
4	ISSUED FOR CONSTRUCTION	21/12/80